

East of Booth
300

LEGEND:


- (9) Interactive Ipads
TAK-999_AATD_EASL_2025_A
ATD digital infographic
VV-MEDMAT-119654.
- Versatile LED screen
- Looped Video playing Patient testimonials
and Matching Experience
- Built in LED Floor standing truss
and Anchor system to house a
9' x 5.5' LED Video Wall.
- Built in anchoring system for
two 43" Touch Screen monitors
with access to android based
Smart touch platform from inside
of storage closet.
- Touch Screen Sizing TBD Booth
Vertical Panel
VV-MEDMAT-123001
Dr. Match Profile
- Fascade Graphic finishes
to Client Specifications

ELECTRICAL LEGEND

	MAIN POWER
	RECEPTACLE OUTLET - 500 WATT
	EXTENSION CORD

Hanging sign
18' x 18' x 20' H

Redwood Trial
Recruitment

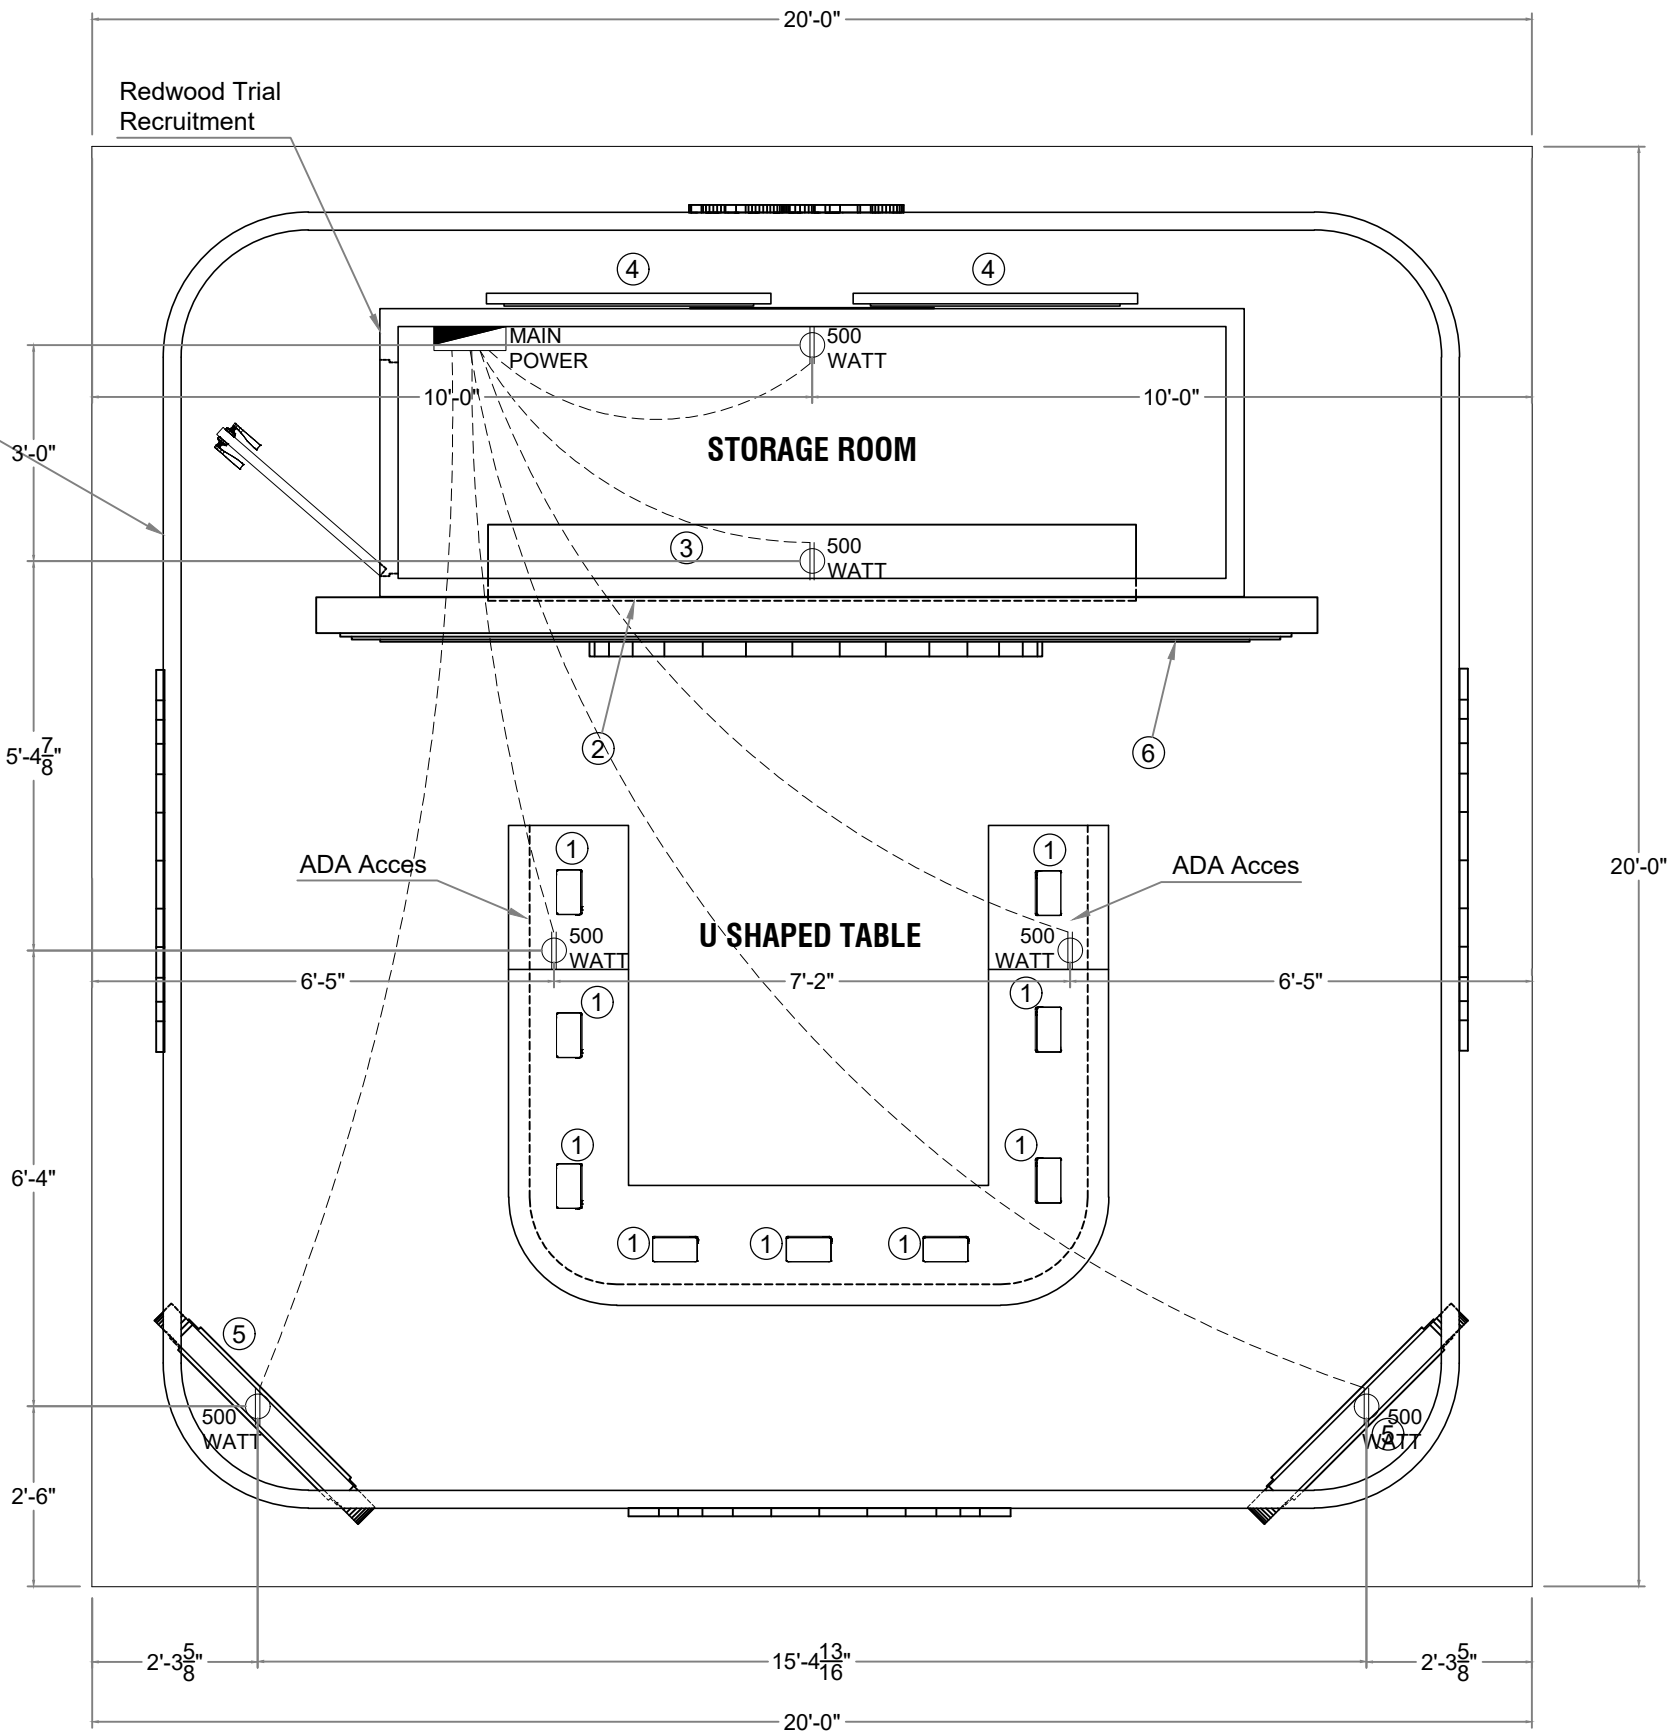

01

ELECTRICAL PLAN

SCALE: 3/8" = 1'-0"

South of
Booth #500

01-SEP25-AR

PROJECT:

DESCRIPTION:

DRAWING VERSION

DATE: DRAWN

09-25 L.A.F.

SCALE: INDICATED

SHEET:

E.1

ANSI Full Bleed B (17.00 X 11.00 Inches)